


COVER

Building Permit - Unit Type C2

124-126 Lockhart St, Como, WA 6152


| CONTENT |                                |             |
|---------|--------------------------------|-------------|
| D0.00   | Cover Page                     |             |
| D1.01   | Floor plans                    | 1:100       |
| D1.02   | Floor plans                    | 1:100       |
| D2.01   | Elevations and window schedule | 1:50        |
| D3.01   | Sections                       | 1:50        |
| D3.02   | Stairs + Lift details          | 1:10, 1:50  |
| D4.01   | Details                        |             |
| D4.02   | Details                        |             |
| D5.01   | Room Layouts                   | 1:50, 1:100 |

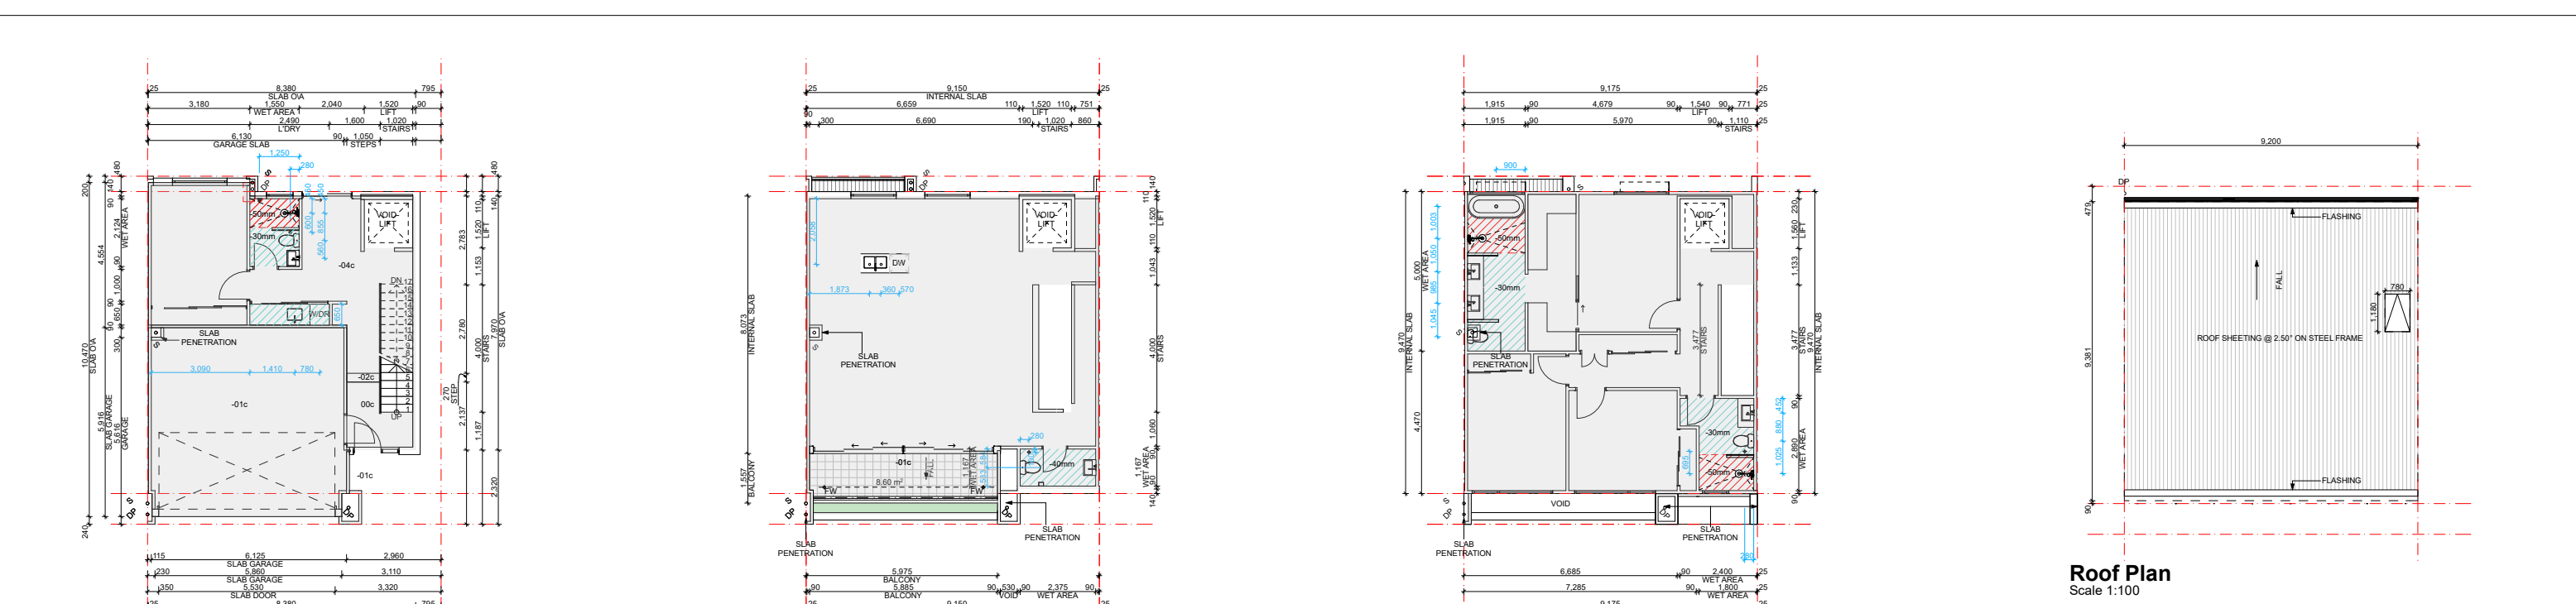


Ground Floor - Slab Setout Plan  
Scale 1:100

First Floor - Slab Setout Plan  
Scale 1:100


Second Floor - Slab Setout Plan  
Scale 1:100

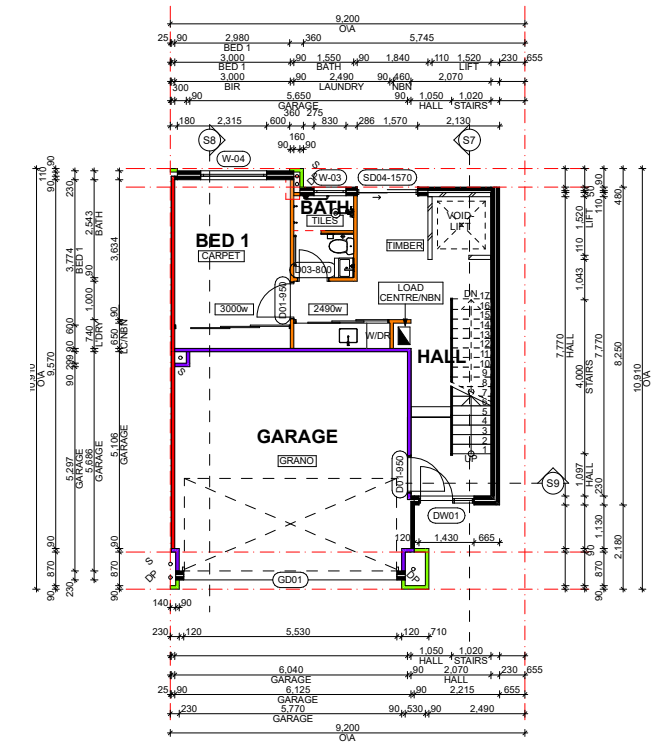

Ground Floor - Type C2  
Scale 1:100

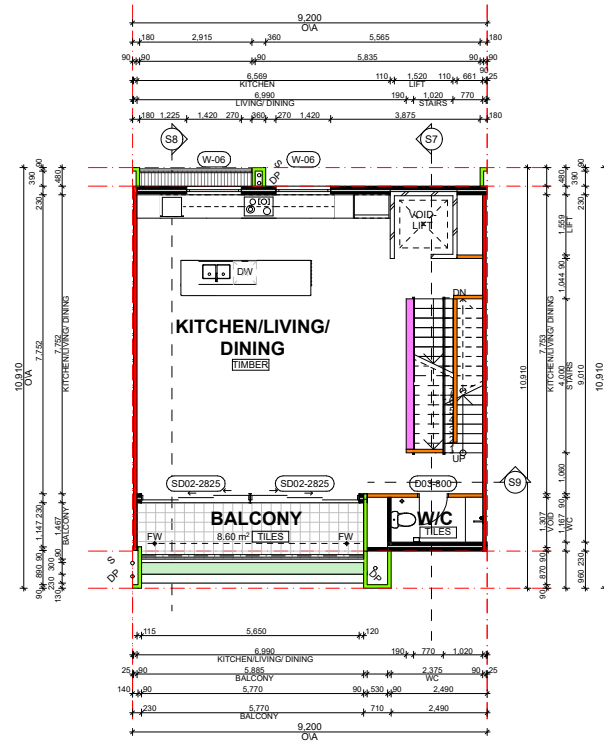

First Floor - Type C2  
Scale 1:100

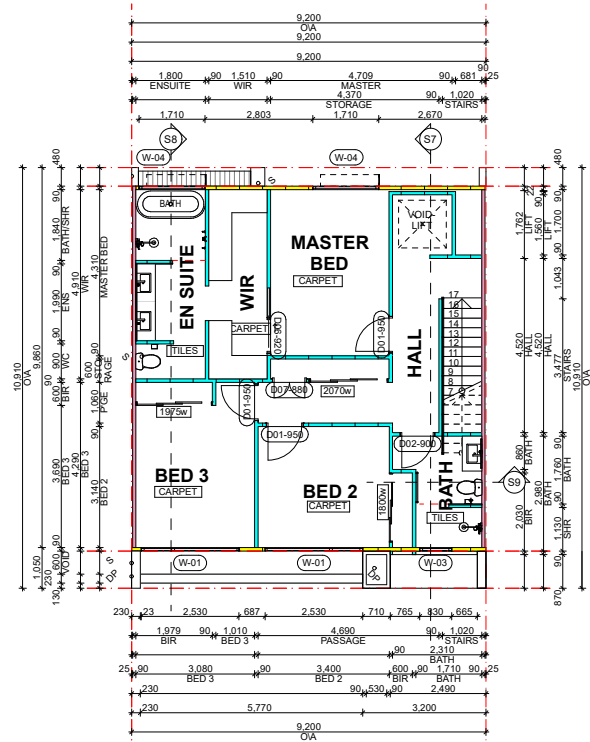

Second Floor - Type C2  
Scale 1:100

| Type C2      |                 |                        |
|--------------|-----------------|------------------------|
| Floor        | Category        | Area (m <sup>2</sup> ) |
| Ground floor | Total           | 80.01                  |
|              | Residence       | 44.4                   |
|              | Garage          | 35.7                   |
| First floor  | Total           | 71.8                   |
|              | Residence       | 63.2                   |
|              | Balcony         | 8.6                    |
| Second floor | Total           | 74.5                   |
|              | Residence       | 74.5                   |
| Summary      | Total Build     | 226.3                  |
| External     | External paving | 13.95                  |
|              | Landscaping     | 12.34                  |
|              | TOTAL           | 26.29                  |

| CEILING LEGEND                                                                                                                                                                                                                                                                                       |                                                                      |
|------------------------------------------------------------------------------------------------------------------------------------------------------------------------------------------------------------------------------------------------------------------------------------------------------|----------------------------------------------------------------------|
| xxx                                                                                                                                                                                                                                                                                                  | CEILING MATERIAL TYPE / CORNICE TYPE. REFER ARCH. MATERIALS SCHEDULE |
| xxx                                                                                                                                                                                                                                                                                                  | FINISHES HEIGHT ABOVE RESPECTIVE INTERNAL STRUCTURAL FLOOR LEVEL     |
| CL-01                                                                                                                                                                                                                                                                                                | FLUSH JOINT PLASTERBOARD CEILING PAINTED FINISH                      |
| CL-02                                                                                                                                                                                                                                                                                                | FLUSH JOINT MOISTURE RESISTANT PLASTERBOARD CEILING PAINTED FINISH   |
| CL-03                                                                                                                                                                                                                                                                                                | 6MM FIBRE CEMENT NEGATIVE JOINT SOFFIT PAINTED FINISH                |
| CEILING NOTES                                                                                                                                                                                                                                                                                        |                                                                      |
| 1. NOMINATED CEILING HEIGHTS ARE TAKEN FROM RESPECTIVE FLOOR PLAN SFL, U.N.O.                                                                                                                                                                                                                        |                                                                      |
| 2. ALL INTERNAL PLASTERBOARD CEILINGS AND BULKHEADS FLUSHED AND PAINTED, U.N.O. REFER INTERIOR SCHEDULE FOR COLOUR.                                                                                                                                                                                  |                                                                      |
| 3. ALL EXTERNAL SOFFIT LINING NEGATIVE JOINTS AND PAINTED, U.N.O.                                                                                                                                                                                                                                    |                                                                      |
| 4. LUMINAIRE SELECTIONS MAY REQUIRE CANISTERS FOR RECESSING INTO CONCRETE SOFFIT BUILDER TO ALLOW.                                                                                                                                                                                                   |                                                                      |
| 5. PLASTERBOARD CEILINGS WITHIN WET AREAS AND EXTERNAL ARE TO BE MOISTURE RESISTANT.                                                                                                                                                                                                                 |                                                                      |
| 6. WHERE THERE IS A DROP CEILING TO A HIGH CEILING CORNICE TO THE HIGH CEILING ONLY SQUARE-SET CORNICE FOR DROP CEILING (e.g. KITCHENS, ROBES WITH SLIDING DOORS & LAUNDRY CUPBOARDS)                                                                                                                |                                                                      |
| 7. CORNICES TO FULL CEILING PERIMETER INCLUDING WHERE CEILING MEETS BULKHEAD/DROPPED CEILINGS EXCEPTIONS AS BELOW:<br>- WHERE CABINET TOPS FINISH AT CEILING LEVEL STOP CORNICE AT CABINET TOP TRIMS/SCRIBER (DO NOT CONTINUE IN FRONT OF TOP TRIMS)<br>- WHERE THERE IS A BLIND RECESS              |                                                                      |
| 8. REFER TO SERVICE CONSULTANT DRAWINGS FOR FULL EXTENT OF ELECTRICAL AND MECHANICAL SERVICES INCLUDING:<br>- LIGHTING LAYOUT<br>- POWER, DATE AND COMMS<br>- DRY FIRE SERVICE EQUIPMENT<br>- MECHANICAL SERVICES<br>- CEILING ACCESS PANELS FOR SERVICES WITHIN CEILING SPACE<br>- WET AREA EXHAUST |                                                                      |

| Type Mark    | Wall List                                                                                            | FRL | Rw  | Insulation |
|--------------|------------------------------------------------------------------------------------------------------|-----|-----|------------|
| WA 011       | 230mm CAVITY STEEL PARTITION WALL + FIRE RATED ACOUSTIC INSULATION + FYRCHCK                         | TBS | TBS | TBS        |
| WA 010       | 190mm BRICKWORK + HWP                                                                                | TBS | TBS | TBS        |
| WA 09        | 90mm BRICK RENDER + HWP INTERNAL + RENDERED TEXTURE COAT EXTERNAL                                    | TBS | TBS | TBS        |
| WA 08 (LIFT) | 110mm BRICKWORK + HWP INTERNAL                                                                       | TBS | TBS | TBS        |
| WA 07        | 230mm CAVITY 90mm MAXI BRICK WITH INTERNAL HWP + MAXI BRICK ACOUSTIC FIRED-RATED BRICKWORK           | TBS | TBS | TBS        |
| WA 06        | 90mm STEEL FRAME                                                                                     | TBS | TBS | TBS        |
| WA 05        | 90mm STEEL FRAME + SELECTED INSULATION + FC OR TIMBER BATTENS + 9mm HARDE EASYLAP WITH TEXTURE PAINT | TBS | TBS | TBS        |
| WA 04        | 90mm FACE PARTITION BRICK WITH RENDERED TEXTURE COAT                                                 | TBS | TBS | TBS        |
| WA 03        | 90mm FACE PARTITION BRICKWORK WITH HWP INSIDE                                                        | TBS | TBS | TBS        |
| WA 02        | 90mm PARTITION BRICK + HWP                                                                           | TBS | TBS | TBS        |
| WA 01        | 230mm CAVITY 90mm MAXI BRICK WITH INTERNAL HWP + MAXI BRICK ACOUSTIC FIRED-RATED BRICKWORK           | TBS | TBS | TBS        |



(08) 6243 6405  
0438420344  
urbanize@urbanize.com.au

| 29.07.26 | A   | Re-Issue for Consultants |
|----------|-----|--------------------------|
| 26.06.26 | -   | Issue for Consultants    |
| DATE     | REV | REASON FOR ISSUE         |
|          |     |                          |


CONTRACTOR TO CHECK ALL DIMENSIONS & LEVELS ON SITE BEFORE COMMENCING ANY WORK OR PREPARING ANY SHOP DRAWINGS. FIGURED DIMENSIONS TAKE PRECEDENCE OVER MEASUREMENTS MANUALLY SCALED OFF DRAWINGS. LARGE SCALE DWGS TAKE PRECEDENCE OVER SMALLER SCALE DWGS.

COMO TOWNHOUSE DEVELOPMENT  
124-126 Lockhart St, Como, WA 6152


Sheet Name  
**Floor plans**

Building Permit


|                                  |            |                                                                                       |       |
|----------------------------------|------------|---------------------------------------------------------------------------------------|-------|
| DRAWN                            | ST         | DESIGNED                                                                              | zz    |
| CHECKED                          | SM         | PRINCIPAL                                                                             |       |
| DATE                             | 29/07/2026 | Principal                                                                             |       |
| PROJECT No.                      | 630-GRI    | DRAWING No.                                                                           | REV.  |
| Scale as shown - Half Scale @ A3 |            |  | D1.01 |
|                                  |            |                                                                                       | Rev A |

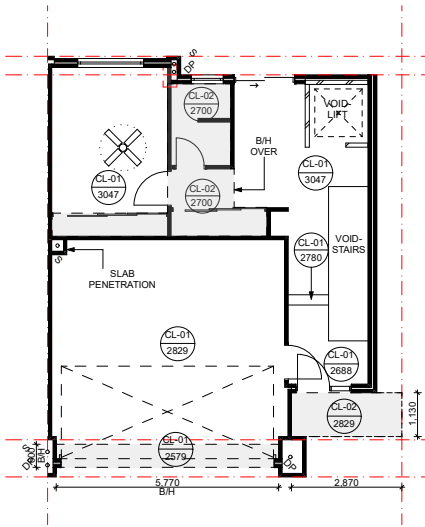

Ground Floor - Ceiling Plan  
Scale 1:100

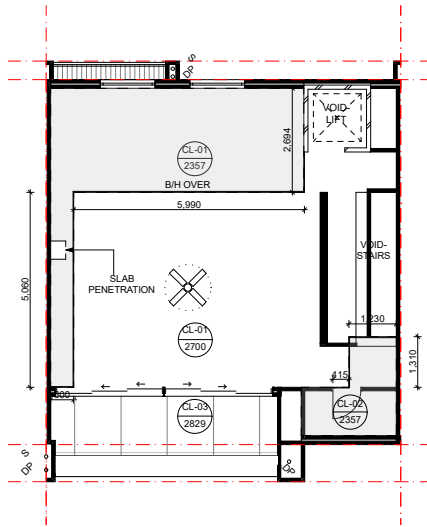

First Floor - Ceiling Plan  
Scale 1:100

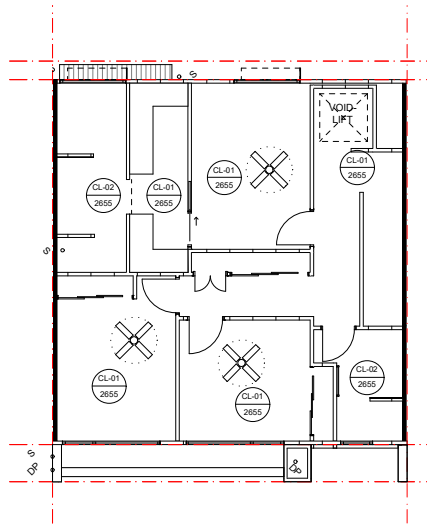

Second Floor - Ceiling Plan  
Scale 1:100

| Type C2      |                 |                        |
|--------------|-----------------|------------------------|
| Floor        | Category        | Area (m <sup>2</sup> ) |
| Ground floor | Total           | 80.01                  |
|              | Residence       | 44.4                   |
|              | Garage          | 35.7                   |
| First floor  | Total           | 71.8                   |
|              | Residence       | 63.2                   |
|              | Balcony         | 8.6                    |
| Second floor | Total           | 74.5                   |
|              | Residence       | 74.5                   |
| Summary      | Total Build     | 226.3                  |
| External     | External paving | 13.95                  |
|              | Landscaping     | 12.34                  |
|              | TOTAL           | 26.29                  |

| CEILING LEGEND                                                                                                                                                                                                                                                                                            |                                                                            |
|-----------------------------------------------------------------------------------------------------------------------------------------------------------------------------------------------------------------------------------------------------------------------------------------------------------|----------------------------------------------------------------------------|
| <div>xxx</div> <div>xxx</div>                                                                                                                                                                                                                                                                             | CEILING MATERIAL TYPE / CORNICE TYPE.<br>REFER ARCH.<br>MATERIALS SCHEDULE |
|                                                                                                                                                                                                                                                                                                           | FINISHES HEIGHT ABOVE RESPECTIVE<br>INTERNAL<br>STRUCTURAL FLOOR LEVEL     |
| CL-01                                                                                                                                                                                                                                                                                                     | FLUSH JOINT PLASTERBOARD<br>CEILING PAINTED FINISH                         |
| CL-02                                                                                                                                                                                                                                                                                                     | FLUSH JOINT MOISTURE RESISTANT<br>PLASTERBOARD CEILING PAINTED FINISH      |
| CL-03                                                                                                                                                                                                                                                                                                     | 6MM FIBRE CEMENT NEGATIVE JOINT SOFFIT<br>PAINTED FINISH                   |
| CEILING NOTES                                                                                                                                                                                                                                                                                             |                                                                            |
| 1.NOMINATED CEILING HEIGHTS ARE TAKEN FROM RESPECTIVE FLOOR<br>PLAN SFL,U.N.O.                                                                                                                                                                                                                            |                                                                            |
| 2.ALL INTERNAL PLASTERBOARD CEILINGS AND BULKHEADS FLUSHED<br>AND PAINTED, U.N.O.<br>REFER INTERIOR SCHEDULE FOR COLOUR.                                                                                                                                                                                  |                                                                            |
| 3.ALL EXTERNAL SOFFIT LINING NEGATIVE JOINTS AND PAINTED,U.N.O.                                                                                                                                                                                                                                           |                                                                            |
| 4.LUMINAIRE SELECTIONS MAY REQUIRE CANISTERS FOR RECESSING<br>INTO CONCRETE SOFFIT BUILDER TO ALLOW.                                                                                                                                                                                                      |                                                                            |
| 5.PLASTERBOARD CEILINGS WITHIN WET AREAS AND EXTERNAL ARE<br>TO BE MOISTURE RESISTANT.                                                                                                                                                                                                                    |                                                                            |
| 6.WHERE THERE IS A DROP CEILING TO A HIGH CEILING CORNICE TO<br>THE HIGH CEILING ONLY SQUARE-SET CORNICE FOR DROP CEILING<br>(e . KITCHENS, ROBES WITH SLIDING DOORS & LAUNDRY CUPBOARDS)                                                                                                                 |                                                                            |
| 7.CORNICES TO FULL CEILING PERIMETER INCLUDING WHERE CEILING<br>MEETS BULKHEAD/DROPPED CEILINGS EXCEPTIONS AS BELOW:<br>- WHERE CABINET TOPS FINISH AT CEILING LEVEL STOP CORNICE AT<br>CABINET TOP TRIMS/SCRIBER (DO NOT CONTINUE IN FRONT OF TOP<br>TRIMS)<br>- WHERE THERE IS A BLIND RECESS           |                                                                            |
| 8.REFER TO SERVICE CONSULTANT DRAWINGS FOR FULL EXTENT OF<br>ELECTRICAL AND<br>MECHANICAL SERVICES INCLUDING:<br>- LIGHTING LAYOUT<br>- POWER, DATE AND COMMS<br>- DRY FIRE SERVICE EQUIPMENT<br>- MECHANICAL SERVICES<br>- CEILING ACCESS PANELS FOR SERVICES WITHIN CEILING SPACE<br>- WET AREA EXHAUST |                                                                            |

URBANIZE

(08) 6243 6405

0438420344

[urbanize@urbanize.com.au](mailto:urbanize@urbanize.com.au)

|          |     |                          |  |    |  |
|----------|-----|--------------------------|--|----|--|
|          |     |                          |  |    |  |
|          |     |                          |  |    |  |
|          |     |                          |  |    |  |
|          |     |                          |  |    |  |
| 29.07.26 | A   | Re-Issue for Consultants |  |    |  |
| 26.06.26 | -   | Issue for Consultants    |  |    |  |
| DATE     | REV | REASON FOR ISSUE         |  | BY |  |

CONTRACTOR TO CHECK ALL DIMENSIONS &  
LEVELS ON SITE BEFORE COMMENCING ANY  
WORK OR PREPARING ANY SHOP DRAWINGS.  
FIGURED DIMENSIONS TAKE PRECEDENCE  
OVER MEASUREMENTS MANUALLY SCALED  
OFF DRAWINGS.  
LARGE SCALE DWGS TAKE PRECEDENCE  
OVER SMALLER SCALE DWGS.


COMO TOWNHOUSE DEVELOPMENT  
124-126 Lockhart St, Como, WA 6152

Sheet Name

Floor plans


Building Permit

|                                     |            |             |       |
|-------------------------------------|------------|-------------|-------|
| DRAWN                               | ST         | DESIGNED    | zz    |
| CHECKED                             | SM         | PRINCIPAL   |       |
| DATE                                | 29/07/2026 | Principal   |       |
| PROJECT No.                         | 630-GRI    | DRAWING No. | REV.  |
| Scale as shown -<br>Half Scale @ A3 |            | D1.02       | Rev A |

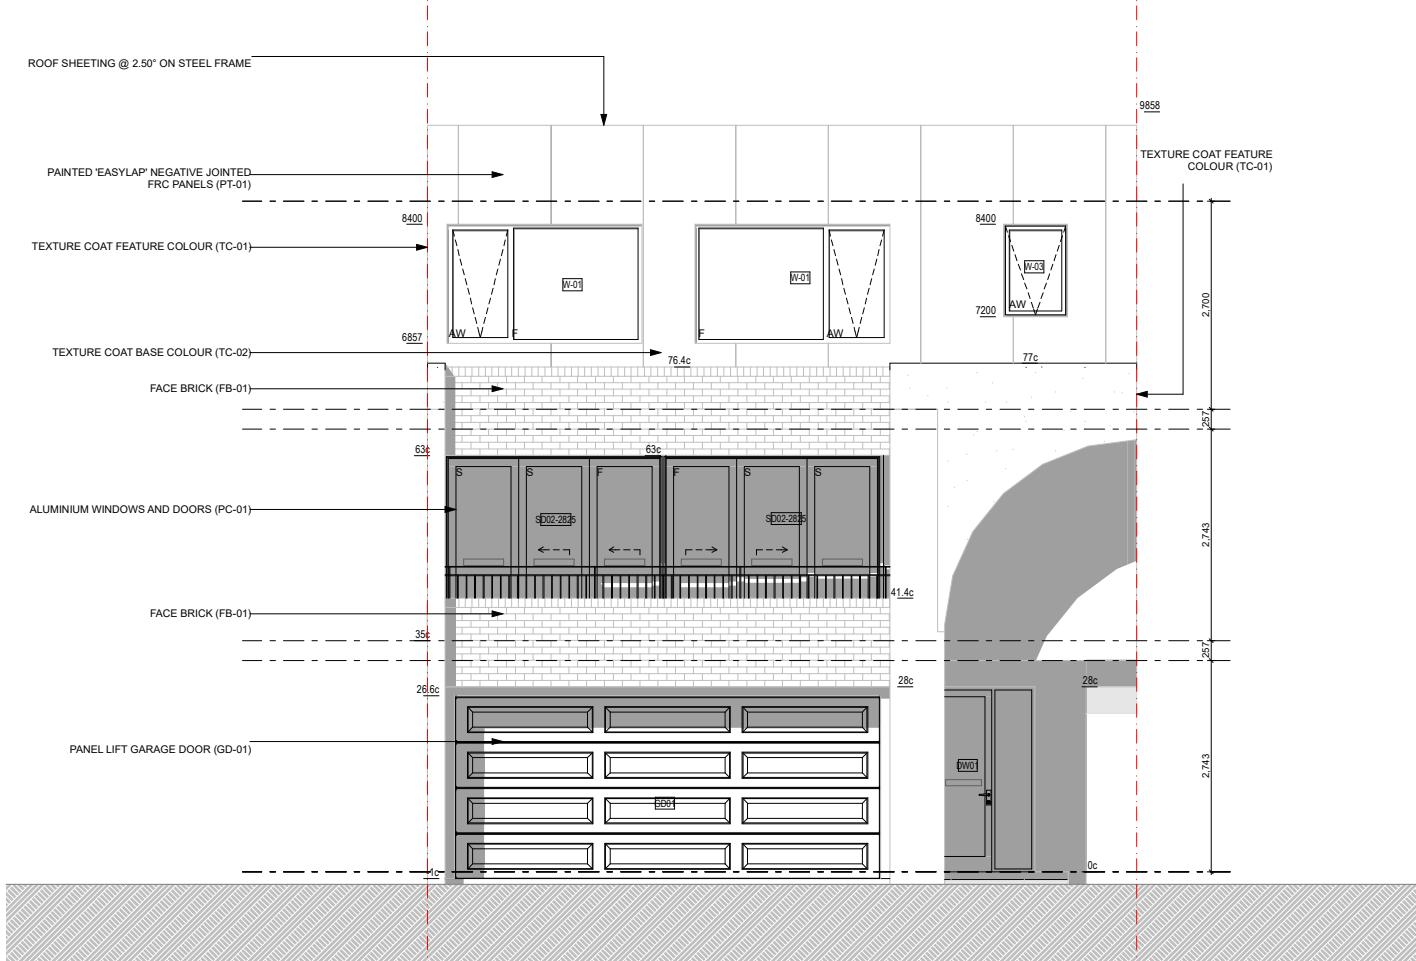

TYPE C2 FRONT ELEVATION


Scale 1:50

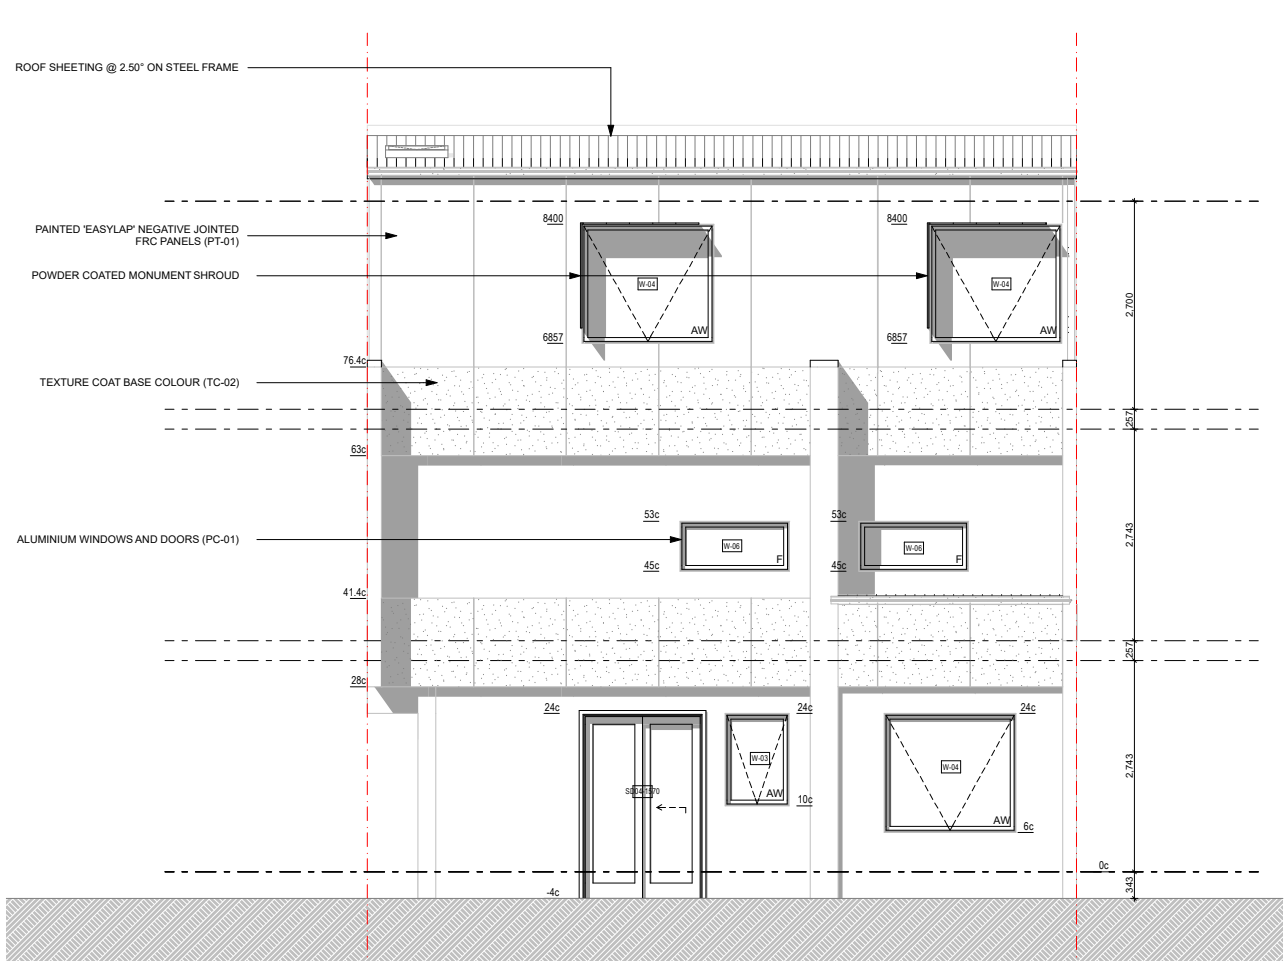

TYPE C2 REAR ELEVATION

Scale 1:50

| Door & Window Schedule |           |     |                 |           |                    |         |          |
|------------------------|-----------|-----|-----------------|-----------|--------------------|---------|----------|
| Storey                 | Item      | Qty | Type            | Frame     | Nominal W x H Size | Glazing | Remarks  |
| Ground Floor           | D01-950   | 2   | Internal door   | Steel     | 950x2,400          | GL-01   |          |
|                        | D03-800   | 1   | Internal door   | Steel     | 800x2,400          | GL-01   |          |
|                        | DW01      | 1   | Entry door      | Steel     | 1,430x2,400        | GL-01   |          |
|                        | GD01      | 1   | Garage door     | Steel     | 5,530x2,400        | GL-01   |          |
|                        | SD04-1570 | 1   | External slider | Steel     | 1,570x2,400        | GL-01   |          |
|                        | W-03      | 1   | Awning window   | Aluminium | 830x1,200          | GL-01   |          |
|                        | W-04      | 1   | Awning window   | Aluminium | 1,710x1,543        | GL-01   |          |
| First Floor            | D03-800   | 1   | Internal door   | Steel     | 800x2,400          | GL-01   |          |
|                        | SD02-2825 | 2   | External slider | Steel     | 2,825x2,400        | GL-01   |          |
|                        | W-06      | 2   | Fixed window    | Aluminium | 1,420x650          | GL-01   |          |
| Second Floor           | D01-950   | 3   | Internal door   | Steel     | 950x2,400          | GL-01   |          |
|                        | D02-900   | 1   | Internal door   | Steel     | 900x2,400          | GL-01   |          |
|                        | D06-820   | 1   | Cavity slider   | Steel     | 820x2,100          | GL-01   |          |
|                        | D07-880   | 1   | Internal door   | Aluminium | 878x2,100          | GL-01   | STORAGE  |
|                        | W-01      | 2   | Awning window   | Aluminium | 2,530x1,543        | GL-01   |          |
|                        | W-03      | 1   | Awning window   | Aluminium | 830x1,200          | GL-01   |          |
|                        | W-04      | 2   | Awning window   | Aluminium | 1,710x1,543        | GL-01   |          |
| Roof                   | SKY - 001 | 1   | Fixed window    | Aluminium | ---                | GL-01   | SKYLIGHT |

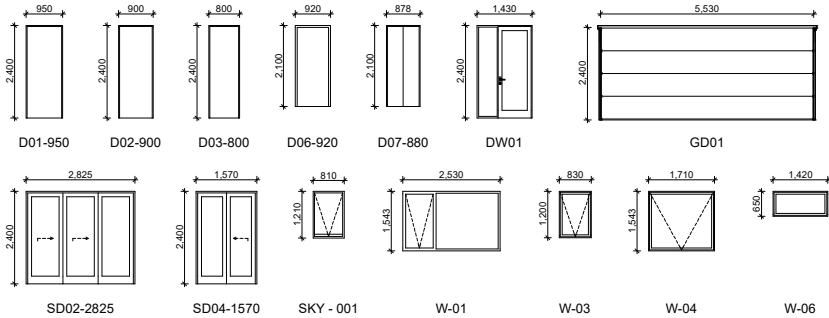

ALL SLIDING DOORS ARE TO BE PROVIDED AN OPAQUE BAND TO ABCB HOUSING PROVISIONS 2022 SECTION 8.4.7

CEILING LEGEND

|       |                                                                      |
|-------|----------------------------------------------------------------------|
| XXX   | CEILING MATERIAL TYPE / CORNICE TYPE. REFER ARCH. MATERIALS SCHEDULE |
| XXX   | FINISHES HEIGHT ABOVE RESPECTIVE INTERNAL STRUCTURAL FLOOR LEVEL     |
| CL-01 | FLUSH JOINT PLASTERBOARD CEILING PAINTED FINISH                      |
| CL-02 | FLUSH JOINT MOISTURE RESISTANT PLASTERBOARD CEILING PAINTED FINISH   |
| CL-03 | 6MM FIBRE CEMENT NEGATIVE JOINT SOFFIT PAINTED FINISH                |

URBANIZE

(08) 6243 6405

0438420344

urbanize@urbanize.com.au

|          |     |                          |  |    |  |
|----------|-----|--------------------------|--|----|--|
|          |     |                          |  |    |  |
|          |     |                          |  |    |  |
|          |     |                          |  |    |  |
|          |     |                          |  |    |  |
| 29.07.26 | A   | Re-Issue for Consultants |  |    |  |
| 26.06.26 | -   | Issue for Consultants    |  |    |  |
| DATE     | REV | REASON FOR ISSUE         |  | BY |  |

CONTRACTOR TO CHECK ALL DIMENSIONS & LEVELS ON SITE BEFORE COMMENCING ANY WORK OR PREPARING ANY SHOP DRAWINGS. FIGURED DIMENSIONS TAKE PRECEDENCE OVER MEASUREMENTS MANUALLY SCALED OFF DRAWINGS. LARGE SCALE DWGS TAKE PRECEDENCE OVER SMALLER SCALE DWGS.


COMO TOWNHOUSE DEVELOPMENT  
124-126 Lockhart St, Como, WA 6152

Sheet Name


Elevations and window schedule

Building Permit

|                                  |            |             |       |
|----------------------------------|------------|-------------|-------|
| DRAWN                            | ST         | DESIGNED    | zz    |
| CHECKED                          | SM         | PRINCIPAL   |       |
| DATE                             | 29/07/2026 | Principal   |       |
| PROJECT No.                      | 630-GRI    | DRAWING No. | REV.  |
| Scale as shown - Half Scale @ A3 |            | D2.01       | Rev A |

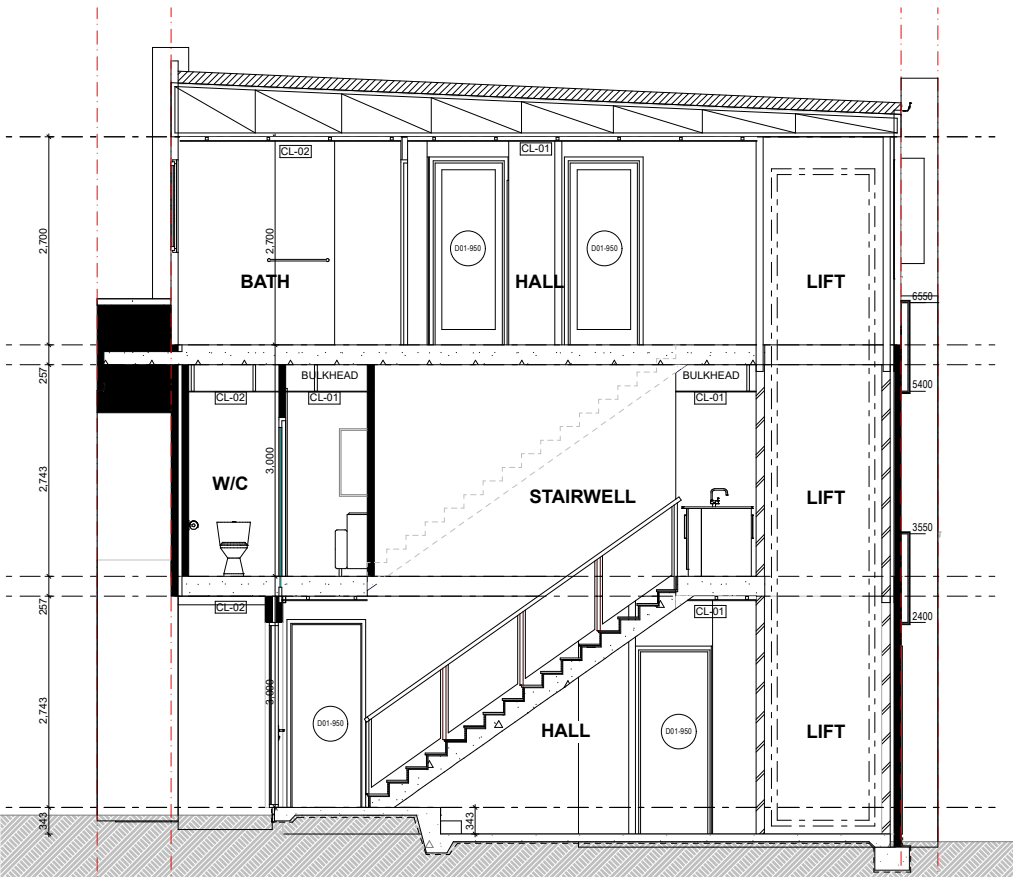

Section 7 - Type C2  
Scale 1:50

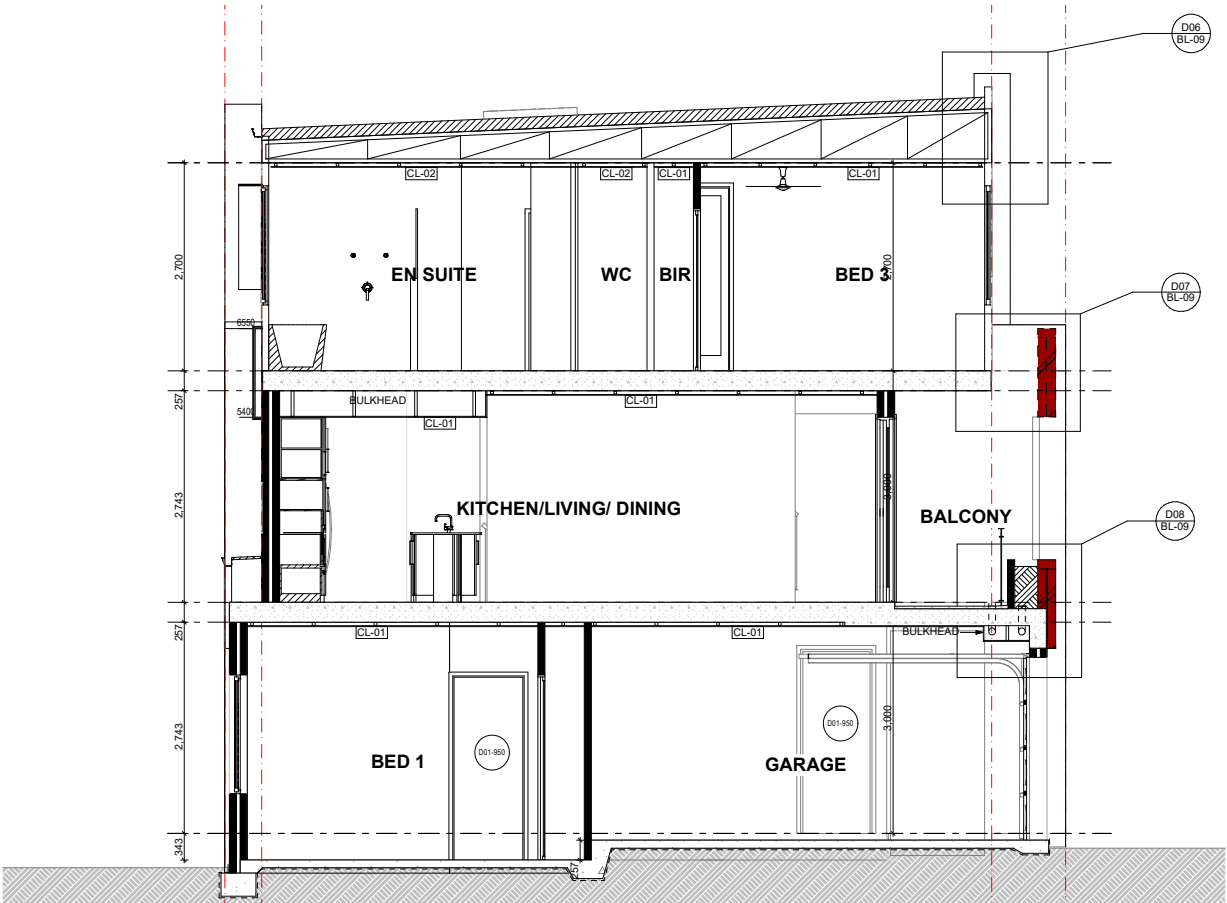

Section 8 - Type C2  
Scale 1:50

ALL SLIDING DOORS ARE TO BE PROVIDED  
AN OPAQUE BAND TO ABCB HOUSING  
PROVISIONS 2022 SECTION 8.4.7

| CEILING LEGEND                      |                                                                            |           |             |
|-------------------------------------|----------------------------------------------------------------------------|-----------|-------------|
| xxx<br>xxx                          | CEILING MATERIAL TYPE / CORNICE TYPE.<br>REFER ARCH.<br>MATERIALS SCHEDULE |           |             |
|                                     | FINISHES HEIGHT ABOVE RESPECTIVE<br>INTERNAL<br>STRUCTURAL FLOOR LEVEL     |           |             |
| CL-01                               | FLUSH JOINT PLASTERBOARD<br>CEILING PAINTED FINISH                         |           |             |
| CL-02                               | FLUSH JOINT MOISTURE RESISTANT<br>PLASTERBOARD CEILING PAINTED FINISH      |           |             |
| CL-03                               | 6MM FIBRE CEMENT NEGATIVE JOINT SOFFIT<br>PAINTED FINISH                   |           |             |
| DRAWN                               | ST                                                                         | DESIGNED  | zz          |
| CHECKED                             | SM                                                                         | PRINCIPAL |             |
| DATE                                | 29/07/2026                                                                 |           | Principal   |
| PROJECT No.                         | 630-GRI                                                                    |           | DRAWING No. |
| Scale as shown -<br>Half Scale @ A3 |                                                                            | D3.01     |             |
|                                     |                                                                            | Rev A     |             |



(08) 6243 6405

0438420344

[urbanize@urbanize.com.au](mailto:urbanize@urbanize.com.au)

| DATE     | REV | REASON FOR ISSUE         | BY |
|----------|-----|--------------------------|----|
| 29.07.26 | A   | Re-Issue for Consultants |    |
| 26.06.26 | -   | Issue for Consultants    |    |

CONTRACTOR TO CHECK ALL DIMENSIONS & LEVELS ON SITE BEFORE COMMENCING ANY WORK OR PREPARING ANY SHOP DRAWINGS. FIGURED DIMENSIONS TAKE PRECEDENCE OVER MEASUREMENTS MANUALLY SCALED OFF DRAWINGS. LARGE SCALE DWGS TAKE PRECEDENCE OVER SMALLER SCALE DWGS.


COMO TOWNHOUSE DEVELOPMENT  
124-126 Lockhart St, Como, WA 6152

Sheet Name  
**Sections**


Building Permit

|                                     |            |           |             |
|-------------------------------------|------------|-----------|-------------|
| DRAWN                               | ST         | DESIGNED  | zz          |
| CHECKED                             | SM         | PRINCIPAL |             |
| DATE                                | 29/07/2026 |           | Principal   |
| PROJECT No.                         | 630-GRI    |           | DRAWING No. |
| Scale as shown -<br>Half Scale @ A3 |            | D3.01     |             |
|                                     |            | Rev A     |             |




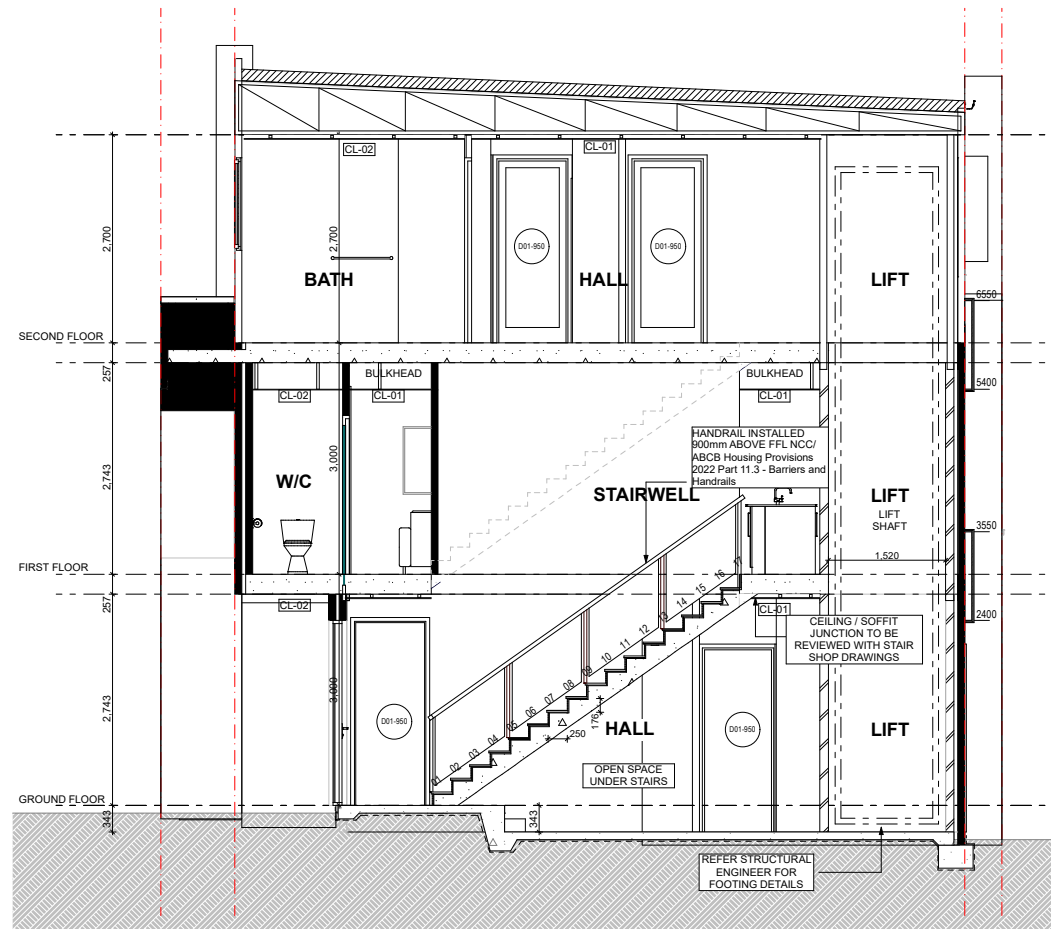

**Section 7 - Lift + Stairs**  
Scale 1:50

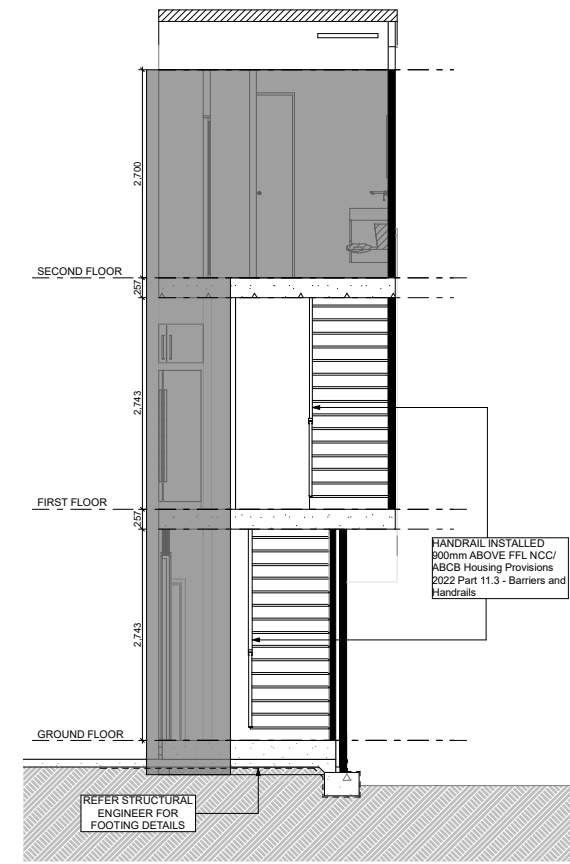


**Type C1- Ensuite**  
Scale 1:50

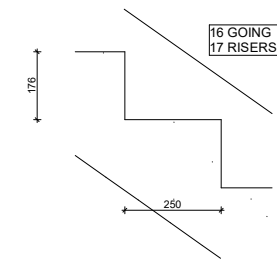


**STAIRS DETAIL**  
Scale 1:10


|                                                                                                                       |       |       |        |
|-----------------------------------------------------------------------------------------------------------------------|-------|-------|--------|
| Stair                                                                                                                 |       |       |        |
| Stair construction is in accordance with NCC/ABCB Housing Provisions 2022 Part 11.2 - Stairways and Ramp construction |       |       |        |
| Riser                                                                                                                 | Max   | Min   | Actual |
| Going                                                                                                                 | Max   | Min   | Actual |
| Slope relationship (2R+G)                                                                                             | Max   | Min   | Actual |
|                                                                                                                       | 700mm | 550mm | 602mm  |

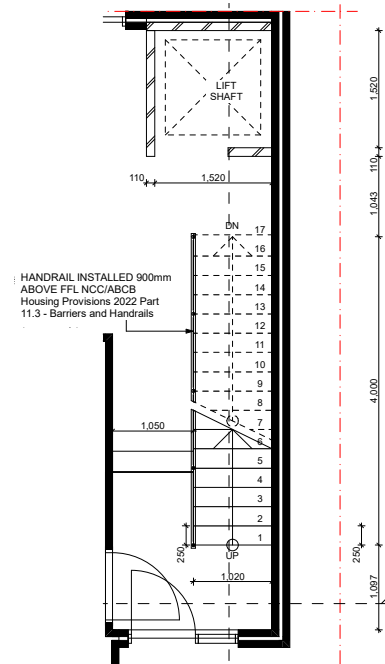

**Ground Floor**  
Scale 1:50

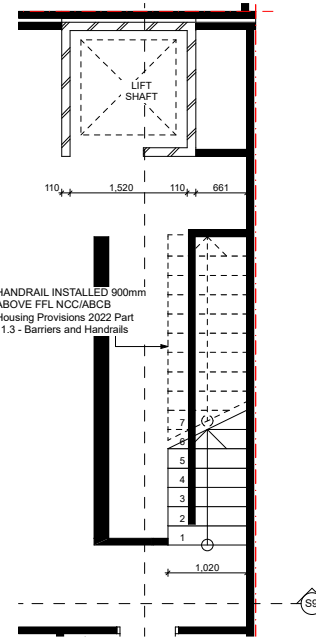

**First Floor**  
Scale 1:50

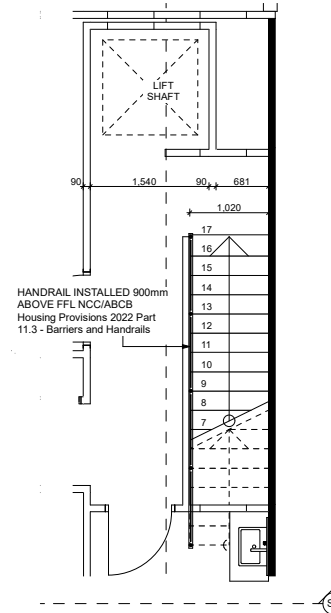

**Second Floor**  
Scale 1:50

**URBANIZE**

(08) 6243 6405  
0438420344  
urbanize@urbanize.com.au

|          |     |                          |    |
|----------|-----|--------------------------|----|
| 29.07.26 | A   | Re-Issue for Consultants | BY |
| 26.06.26 | -   | Issue for Consultants    |    |
| DATE     | REV | REASON FOR ISSUE         | BY |


CONTRACTOR TO CHECK ALL DIMENSIONS & LEVELS ON SITE BEFORE COMMENCING ANY WORK OR PREPARING ANY SHOP DRAWINGS. FIGURED DIMENSIONS TAKE PRECEDENCE OVER MEASUREMENTS MANUALLY SCALED OFF DRAWINGS. LARGE SCALE DWGS TAKE PRECEDENCE OVER SMALLER SCALE DWGS.

COMO TOWNHOUSE DEVELOPMENT  
124-126 Lockhart St, Como, WA 6152


Sheet Name  
**Stairs + Lift details**

Building Permit


|                                  |            |              |       |
|----------------------------------|------------|--------------|-------|
| DRAWN                            | ST         | DESIGNED     | zz    |
| CHECKED                          | SM         | PRINCIPAL    |       |
| DATE                             | 29/07/2026 | Principal    |       |
| PROJECT No.                      | 630-GRI    | DRAWING No.  | REV.  |
| Scale as shown - Half Scale @ A3 |            | <b>D3.02</b> | Rev A |

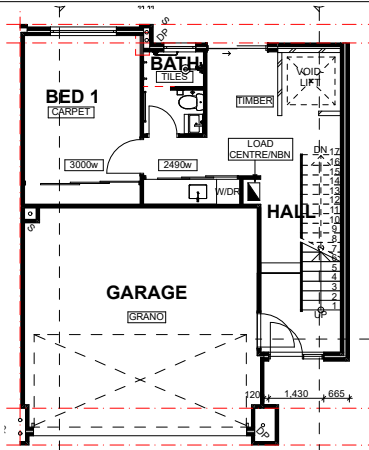

Ground Floor - Type C2  
Scale 1:100

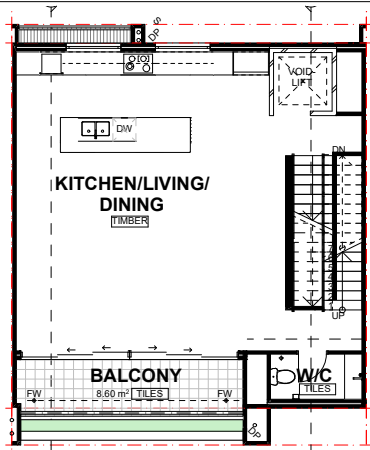


First Floor - Type C2  
Scale 1:100

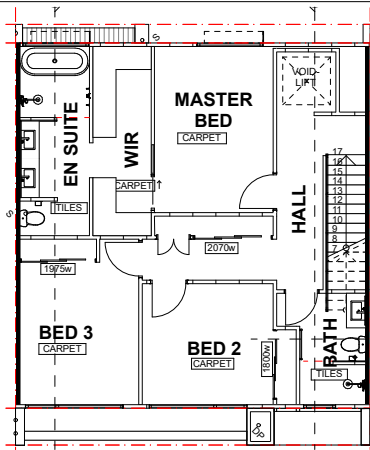


Second Floor - Type C2  
Scale 1:100


NOTE: GLASS SCREEN IS RAISED  
10mm  
ABOVE THE TILING

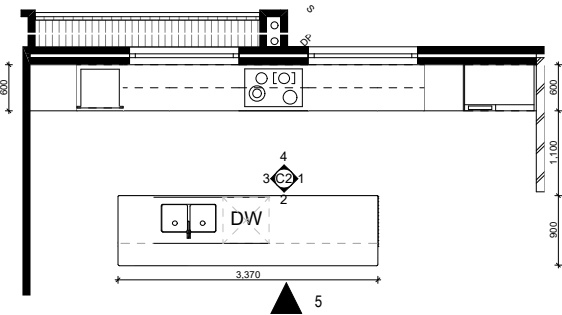


Type A - Kitchen/Pty/Laundry  
Scale 1:50

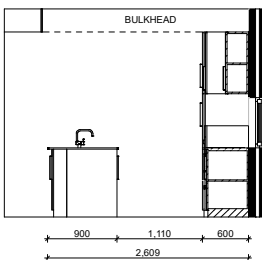


Kitchen 1  
Scale 1:50

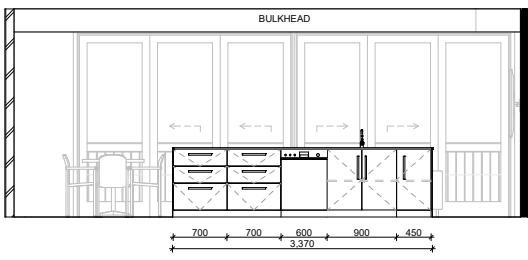


Kitchen 2  
Scale 1:50

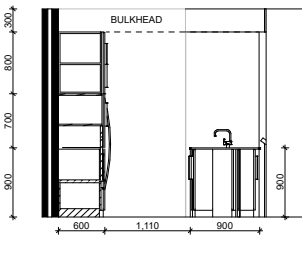


Kitchen 3  
Scale 1:50

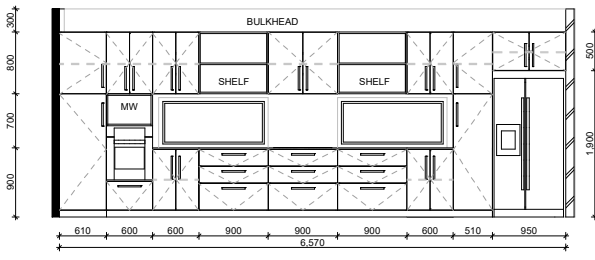


Kitchen 4  
Scale 1:50

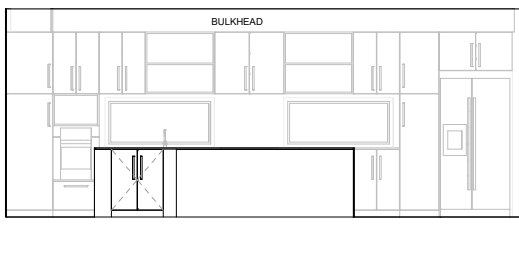


Kitchen 5  
Scale 1:50

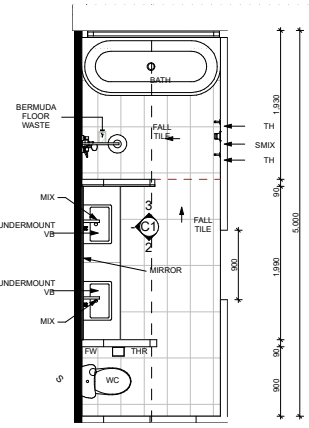


Type C1 - Ensuite  
Scale 1:50

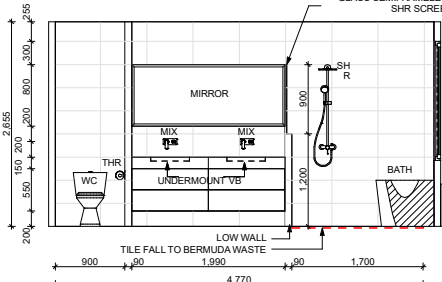


Ensuite 01  
Scale 1:50

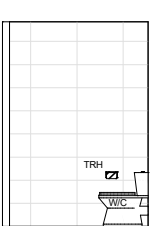


Ensuite 02  
Scale 1:50

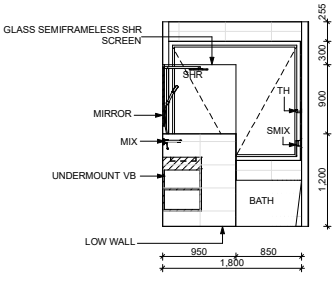


Ensuite 03  
Scale 1:50

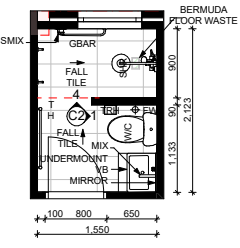


Type A - GF Bath  
Scale 1:50

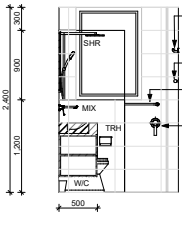


GF Bath 01  
Scale 1:50

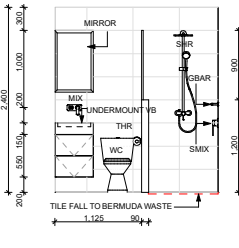


GF Bath 02  
Scale 1:50

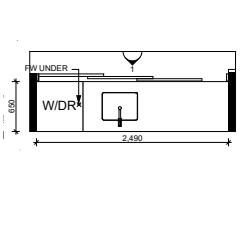


Type A - GF Laundry  
Scale 1:50

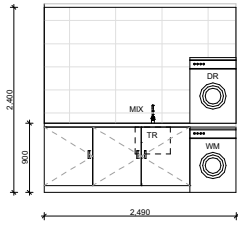


GF Laundry 01  
Scale 1:50

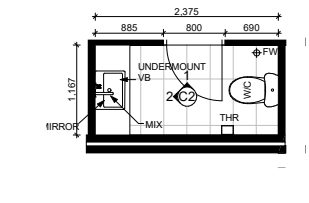


Type C1 - FF floor W/C  
Scale 1:50

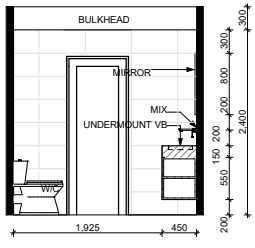


FF WC 01  
Scale 1:50

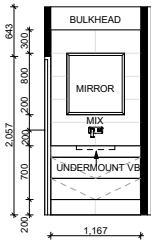


FF WC 02  
Scale 1:50

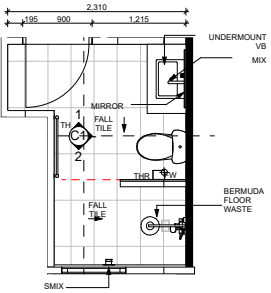


Type C1 - Ensuite  
Scale 1:50

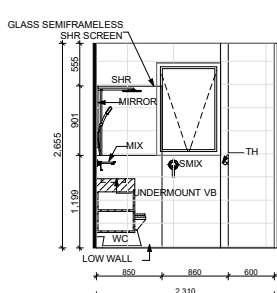

2F Bath 01  
Scale 1:50

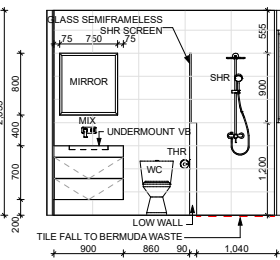

2F Bath 02  
Scale 1:50

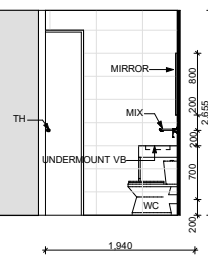

2F Bath 03  
Scale 1:50

| DATE     | REV | REASON FOR ISSUE         | BY |
|----------|-----|--------------------------|----|
| 29.07.26 | A   | Re-Issue for Consultants |    |
| 26.06.26 | -   | Issue for Consultants    |    |

CONTRACTOR TO CHECK ALL DIMENSIONS & LEVELS ON SITE BEFORE COMMENCING ANY WORK OR PREPARING ANY SHOP DRAWINGS. FIGURED DIMENSIONS TAKE PRECEDENCE OVER MEASUREMENTS MANUALLY SCALED OFF DRAWINGS. LARGE SCALE DWGS TAKE PRECEDENCE OVER SMALLER SCALE DWGS.

COMO TOWNHOUSE DEVELOPMENT  
124-126 Lockhart St, Como, WA 6152  
Sheet Name  
Room Layouts

Building Permit

|                                  |            |             |       |
|----------------------------------|------------|-------------|-------|
| DRAWN                            | ST         | DESIGNED    | zz    |
| CHECKED                          | SM         | PRINCIPAL   |       |
| DATE                             | 29/07/2026 | Principal   |       |
| PROJECT No.                      | 630-GRI    | DRAWING No. | REV.  |
| Scale as shown - Half Scale @ A3 |            | D5.01       | Rev A |